


REFLECTED CEILING PLAN GENERAL NOTES

- ALL SPEAKERS, DIFFUSERS, EMERGENCY UNIT BASE PLATES, RECEPTACLES, ACCESS PANELS, AND COVERPLATES IN GYP. BD. CEILING TO BE PAINTED TO MATCH ADJACENT CEILING; SEE ELECTRICAL AND MECHANICAL DRAWINGS FOR LOCATIONS.
- EXIT SIGNS MUST BE INTERNALLY ILLUMINATED.
- CROSS REFERENCE TO BOTH SHEETS A101 AND E200 FOR LIGHTING FIXTURE INFO, SPECIFICATIONS & PLACEMENT. NOTIFY ARCHITECT OF ANY DISCREPANCIES.
- SPRINKLER PLANS AND SPECS TO BE SUBMITTED BY SPRINKLER CONTRACTOR. SPRINKLER CONTRACTOR TO SUBMIT PLANS TO BUILDING DEPARTMENT AND OBTAIN PERMIT. REFER TO SPRINKLER DRAWINGS FOR SPRINKLER INFORMATION IN ALL AREAS.
- ALL WIRING MUST BE IN RIGID CONDUIT.
- DO NOT ABANDON ANY UTILITIES OR MATERIALS WITHIN LEASE SPACE, REMOVE BACK TO SOURCE.
- SUPPORT WIRES FOR CEILING ITEMS MUST NOT BE CONNECTED TO ANY OF LL, MECH, ELEC, PLUMBING OR FIRE PROTECTION PIPING OR EQUIPMENT.

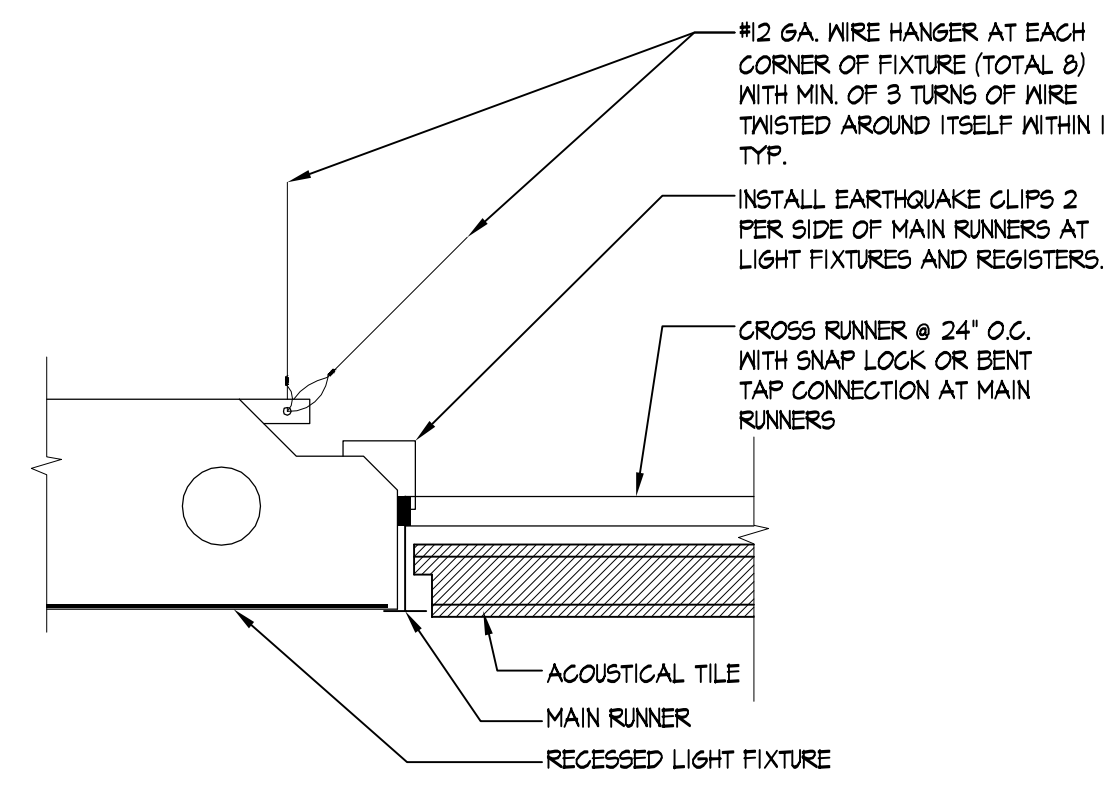

2 LIGHT FIXTURE DETAIL
SCALE: N.T.S.

CEILING PLAN LEGEND	
	EXIST. 2x4 PRISMATIC LIGHTING TO REMAIN
	EXIST. 2x4 PRISMATIC LIGHTING TO BE RELOCATED
	EXIST. 2x2 PRISMATIC LIGHTING TO REMAIN
	EXIST. 2x2 PRISMATIC LIGHTING TO BE RELOCATED
	NEW 1x3 WALL MOUNTED STRIP FIXTURE
	EXIST. EXIT SIGN TO REMAIN
	NEW EXIT SIGNS BY TENANT G.C.
	RELOCATED EXIT SIGNS
	EXIST. SPEAKER TO REMAIN
	NEW SPEAKER BY TENANT G.C.
	RELOCATED SPEAKER
	NEW EXHAUST FAN W/ THERMOSTAT CONTROL
	NEW WALL SWITCH
	RELOCATED WALL SWITCH
	NEW SLOTTED SUPPLY AIR DIFFUSER BY G.C.
	EXIST SLOTTED SUPPLY AIR DIFFUSER TO REMAIN
	EXIST. 2x2 RETURN AIR DIFFUSER TO REMAIN



1 REFLECTED CEILING PLAN
SCALE: 1/8"=1'-0"

EXISTING CEILING TO REMAIN UNLESS OTHERWISE NOTED PER PLANS. G.C. TO REPLACE TILES AND GRID AS REQUIRED

REGISTRATION SEAL

ARCVISION
INCORPORATED
ARCHITECTURE • ENGINEERING • STORE PLANNING
SAINT LOUIS / DALLAS / LAS VEGAS / ORLANDO
1950 CRAIG ROAD, SUITE 300 ST. LOUIS, MO 63146
PH: (314) 415-2400 FAX: (314) 415-2300 www.arcv.com

STIFEL NICOLAUS
501 NORTH BROADWAY
8th FLOOR
ST. LOUIS, MO 63102

PROJECT NO: 090748
DRAWN BY: LUJ
CHECKED BY: BMW
ISSUE DATE: 11/04/09

NAME: _____
DESCRIPTION: _____
REV: _____ DATE: _____

REFLECTED CEILING PLAN

A101